


CONSTRUCTION NOTES

- SYMBOL: (W) TYPICAL
- 2 LIGHTING
- 2.01 DUAL TECHNOLOGY WALL SWITCH SENSOR INFRARED & ULTRASONIC.
-WATTSOPPER# DW-100. -MOUNTED AT +48" A.F.F.
- 2.02 DUAL TECHNOLOGY WALL SWITCH SENSOR INFRARED & ULTRASONIC w/121
RELAYS TO CONTROL. [2] INDEPENDENT CIRCUITS. -WATTSOPPER# DW-200.
-MOUNTED AT +48" A.F.F.
- 2.03 DUAL TECHNOLOGY LINE VOLTAGE CEILING SENSOR INFRARED & ULTRASONIC
360 DEG. 1000 S.F. COVERAGE. -WATTSOPPER# DT-355.
- 2.04 STANDARD LINE VOLTAGE SWITCHING FOR OCCUPANCY SENSOR OVERRIDE.
2.05 J-BOX AT CEILING FOR PENDANT MTD. LIGHT FIXTURE - CONNECT AS REQUIRED.
2.06 LOCATE TO EXTEND DOWN BELOW DUCTWORK & STRUCTURAL BEAM FOR
UNOBSTRUCTED VISUAL ON THE FLOOR - MIN. HT. +8'-8" A.F.F.

FIXTURE SCHEDULE

DESIG.	SYMBOL	QTY WATTS		DESCRIPTION	MANUFACTURER
A1 #/32		10-	F32T8 310 20'	SUSPENDED LINEAR LIGHT FIXTURES - FLUOR	CORELITE 10-NU-27B-2C-AC-UNV-A-C- AC48-JB-20-DL5
A2 #/32		18-	F32T8 558 36'	SUSPENDED LINEAR LIGHT FIXTURES - FLUOR	CORELITE 10-NU-27B-2C-AC-UNV-A-C- AC48-JB-36-DL5
A3 #/32		8-	F32T8 248 16'	SUSPENDED LINEAR LIGHT FIXTURES - FLUOR	CORELITE 10-NU-27B-2C-AC-UNV-A-C- AC48-JB-16-DL5
A4 #/32		4-	F32T8 124 8'	SUSPENDED LINEAR LIGHT FIXTURES - FLUOR	CORELITE 10-NU-27B-2C-AC-UNV-A-C- AC48-JB-8-DL5
A5 #/32		2-	F32T8 62 4'	SUSPENDED LINEAR LIGHT FIXTURES - FLUOR	CORELITE 10-NU-27B-2C-AC-UNV-A-C- AC48-JB-4-DL5
B 2/32		2-	F32T8 62	SURFACE MOUNTED LIGHT FIXTURE - 48W. - FLUOR	METALUX W-232A-UNV-ER81
C1 1/54		1-	F54T5HO 62	SURFACE MOUNTED LIGHT FIXTURE - 48W. - FLUOR	CORELITE RB-WL-17S-C-UNV-SU
CE 1/54		1-	F54T5HO 62	SURFACE MOUNTED LIGHT FIXTURE - 48W. - FLUOR w/ EMERGENCY BALLAST	CORELITE RB-WL-17S-C-E-UNV-SU
D 2/54		2-	F54T5HO 121	SURFACE MOUNTED LIGHT FIXTURE - 48W. - FLUOR	CORELITE 1B-SV-17S-D-120-AC-AC48- JB-8-4-E5
D1 2/54		2-	F54T5HO 121	SURFACE MOUNTED LIGHT FIXTURE - 48W. - FLUOR	CORELITE 1B-SV-17S-D-120-AC-AC48- JB-4-4-E5
F 1/32		1-	CF132W 36	RECESSED CAN DOWN LIGHT FIXTURE	JUNO INDY CBH-126/321 C690CL
G 1/16		1-	MR16 50	RECESSED CAN DOWN LIGHT FIXTURE	JUNO INDY LV44-MR16 LV400AB-B
H 1/2C		1-	JC 50	CEILING MTD. FIXTURE OVER COUNTER	ALFA P450J-57N-XXX 9090J-57N
J 1/13		2-	CFQ3W 25	SURFACE MTD. DRUM FIXTURE	CARRI FRD10IC
E 2/16		2-	MR16 10	EMERGENCY LIGHT FIXTURE- 2 HEADS	DUAL-LITE L22
X 1/18		1-	LED 3	EXIT LIGHT FIXTURE- GREEN LETTERS	DUAL-LITE LX06W
X1 2/18		2-	LED 10	COMBO EXIT-EMERGENCY LIGHT FIXTURE w/ 2 HEADS- GREEN LETTERS	DUAL-LITE LT06W

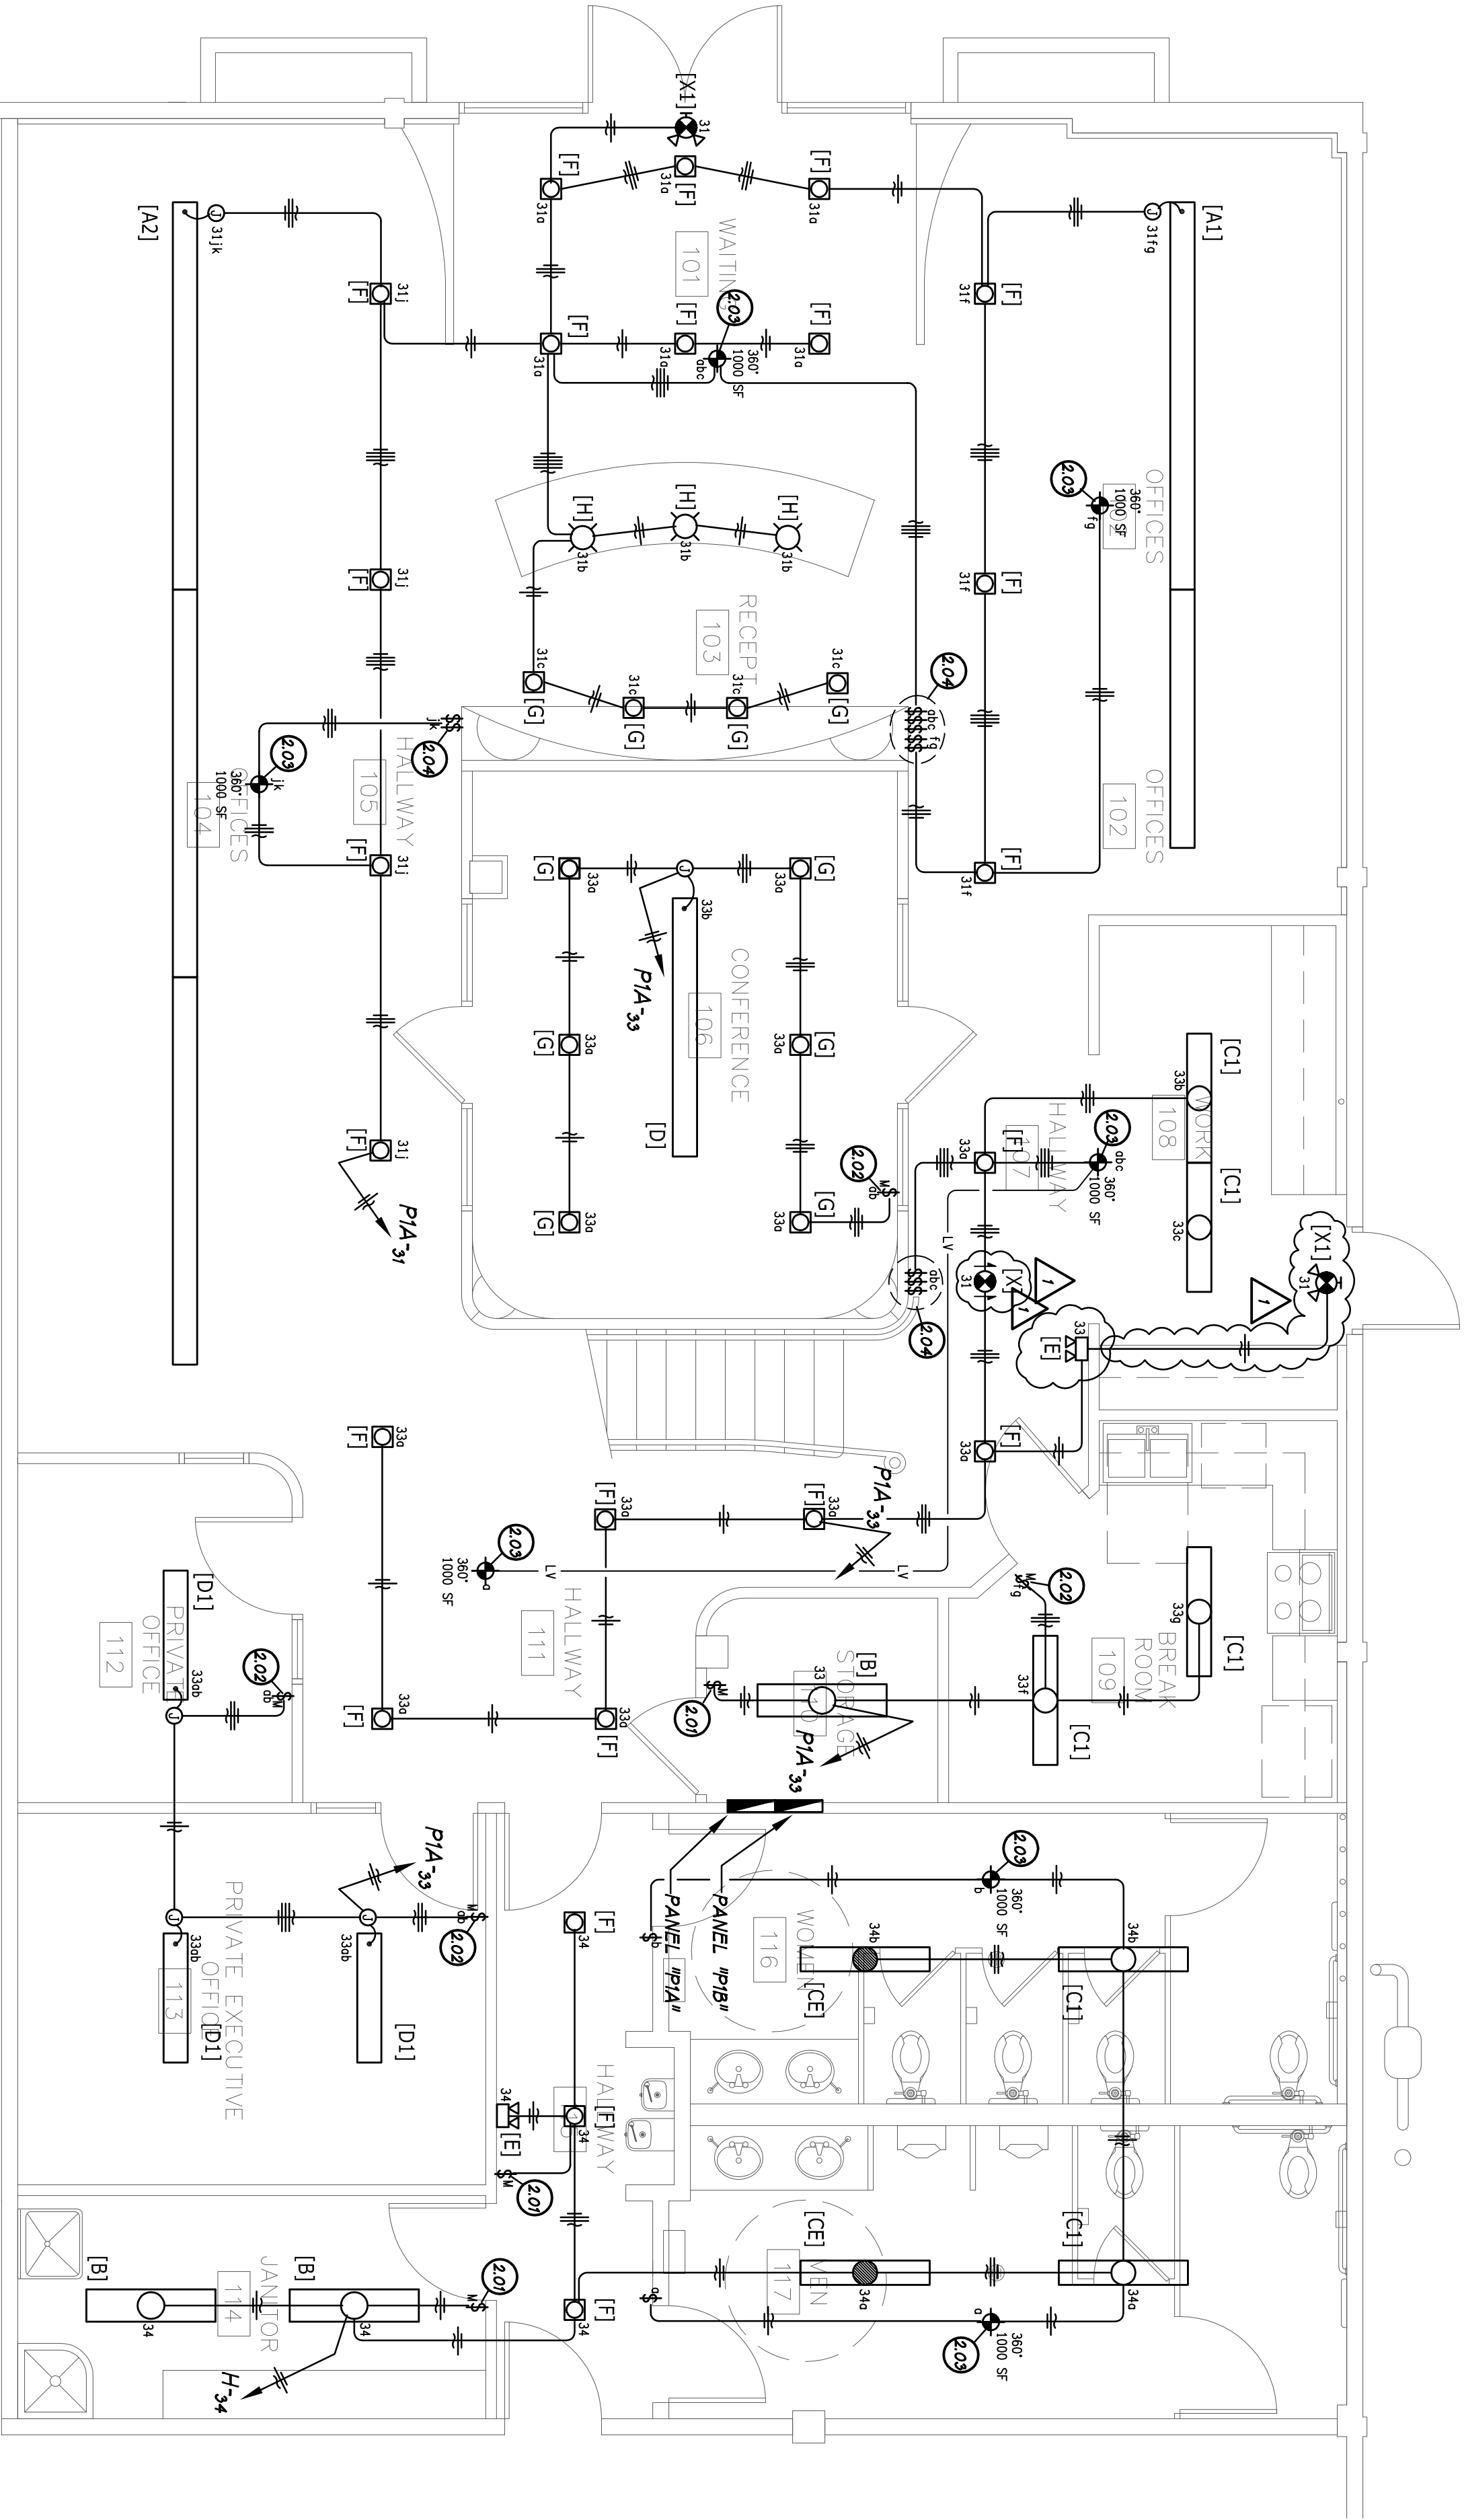

TENANT IMPROVEMENT FOR:

GRANITE REALTY

CORNERSTONE MALL
2000 BRIGGSMORE
MODESTO, CALIFORNIA

REVISIONS:
CITY PLAN OK: 08-10

DRAWN: CAL
DATE: 08-20-10
FILE: 10-440
JOB: 10-440
PRINT DATE:

E2.1

L Street Architects
limited

1414 L Street
Modesto, California 95354
209.575.1415
209.575.4374 Fax
www.lstreetarchitects.com

LIGHTING PLAN – FIRST FLOOR

SCALE:
1/4"=1'-0"

REGISTERED PROFESSIONAL ENGINEER
STATE OF CALIFORNIA
ELECTRICAL
NO. 18788
KEVIN L. PEZZONI
DR. VITO

REGISTERED PROFESSIONAL ARCHITECT
STATE OF CALIFORNIA
ARCHITECTURAL
NO. 15228
KEVIN L. PEZZONI
DR. VITO

MILLER & ASSOCIATES, INC.
CONSULTING ELECTRICAL ENGINEERS
608 BRIMLEY STREET, SUITE 100
FARMERSVILLE, CA 95230
PHONE: 916.222.8800
FAX: 916.222.8801
WWW.MILLER-AND-ASSOCIATES.COM

MILLER & ASSOCIATES, INC.
CONSULTING ELECTRICAL ENGINEERS
608 BRIMLEY STREET, SUITE 100
FARMERSVILLE, CA 95230
PHONE: 916.222.8800
FAX: 916.222.8801
WWW.MILLER-AND-ASSOCIATES.COM

ALL WORK SHALL COMPLY WITH THE REQUIREMENTS OF LOCAL, COUNTY, STATE OR FEDERAL AGENCIES HAVING JURISDICTION. L STREET ARCHITECTS ASSUMES NO RESPONSIBILITY FOR THE SUPERVISION OF CONSTRUCTION OR PROPER EDITION OF THE WORK SHOWN ON THESE DRAWINGS. SAFETY METHODS AND TECHNIQUES OR UNAUTHORIZED CHANGES TO THESE DRAWINGS ARE NOT THE RESPONSIBILITY OF L STREET ARCHITECTS. DEVIATIONS FROM THE ORIGINAL DRAWINGS MUST BE APPROVED IN WRITING PRIOR TO CONSTRUCTION.

THESE DRAWINGS AND ANY INFORMATION CONTAINED HEREIN ARE THE PROPERTY OF L STREET ARCHITECTS. NO PART OF THESE DRAWINGS OR INFORMATION CONTAINED HEREIN MAY BE REPRODUCED OR TRANSMITTED IN ANY FORM OR BY ANY MEANS, ELECTRONIC OR MECHANICAL, INCLUDING PHOTOCOPYING, RECORDING, OR BY ANY INFORMATION STORAGE AND RETRIEVAL SYSTEM, WITHOUT THE WRITTEN PERMISSION OF L STREET ARCHITECTS & COMPANY.