


P-2, 9/23/2010 1:38:34 PM, DWG To PDF.pcd

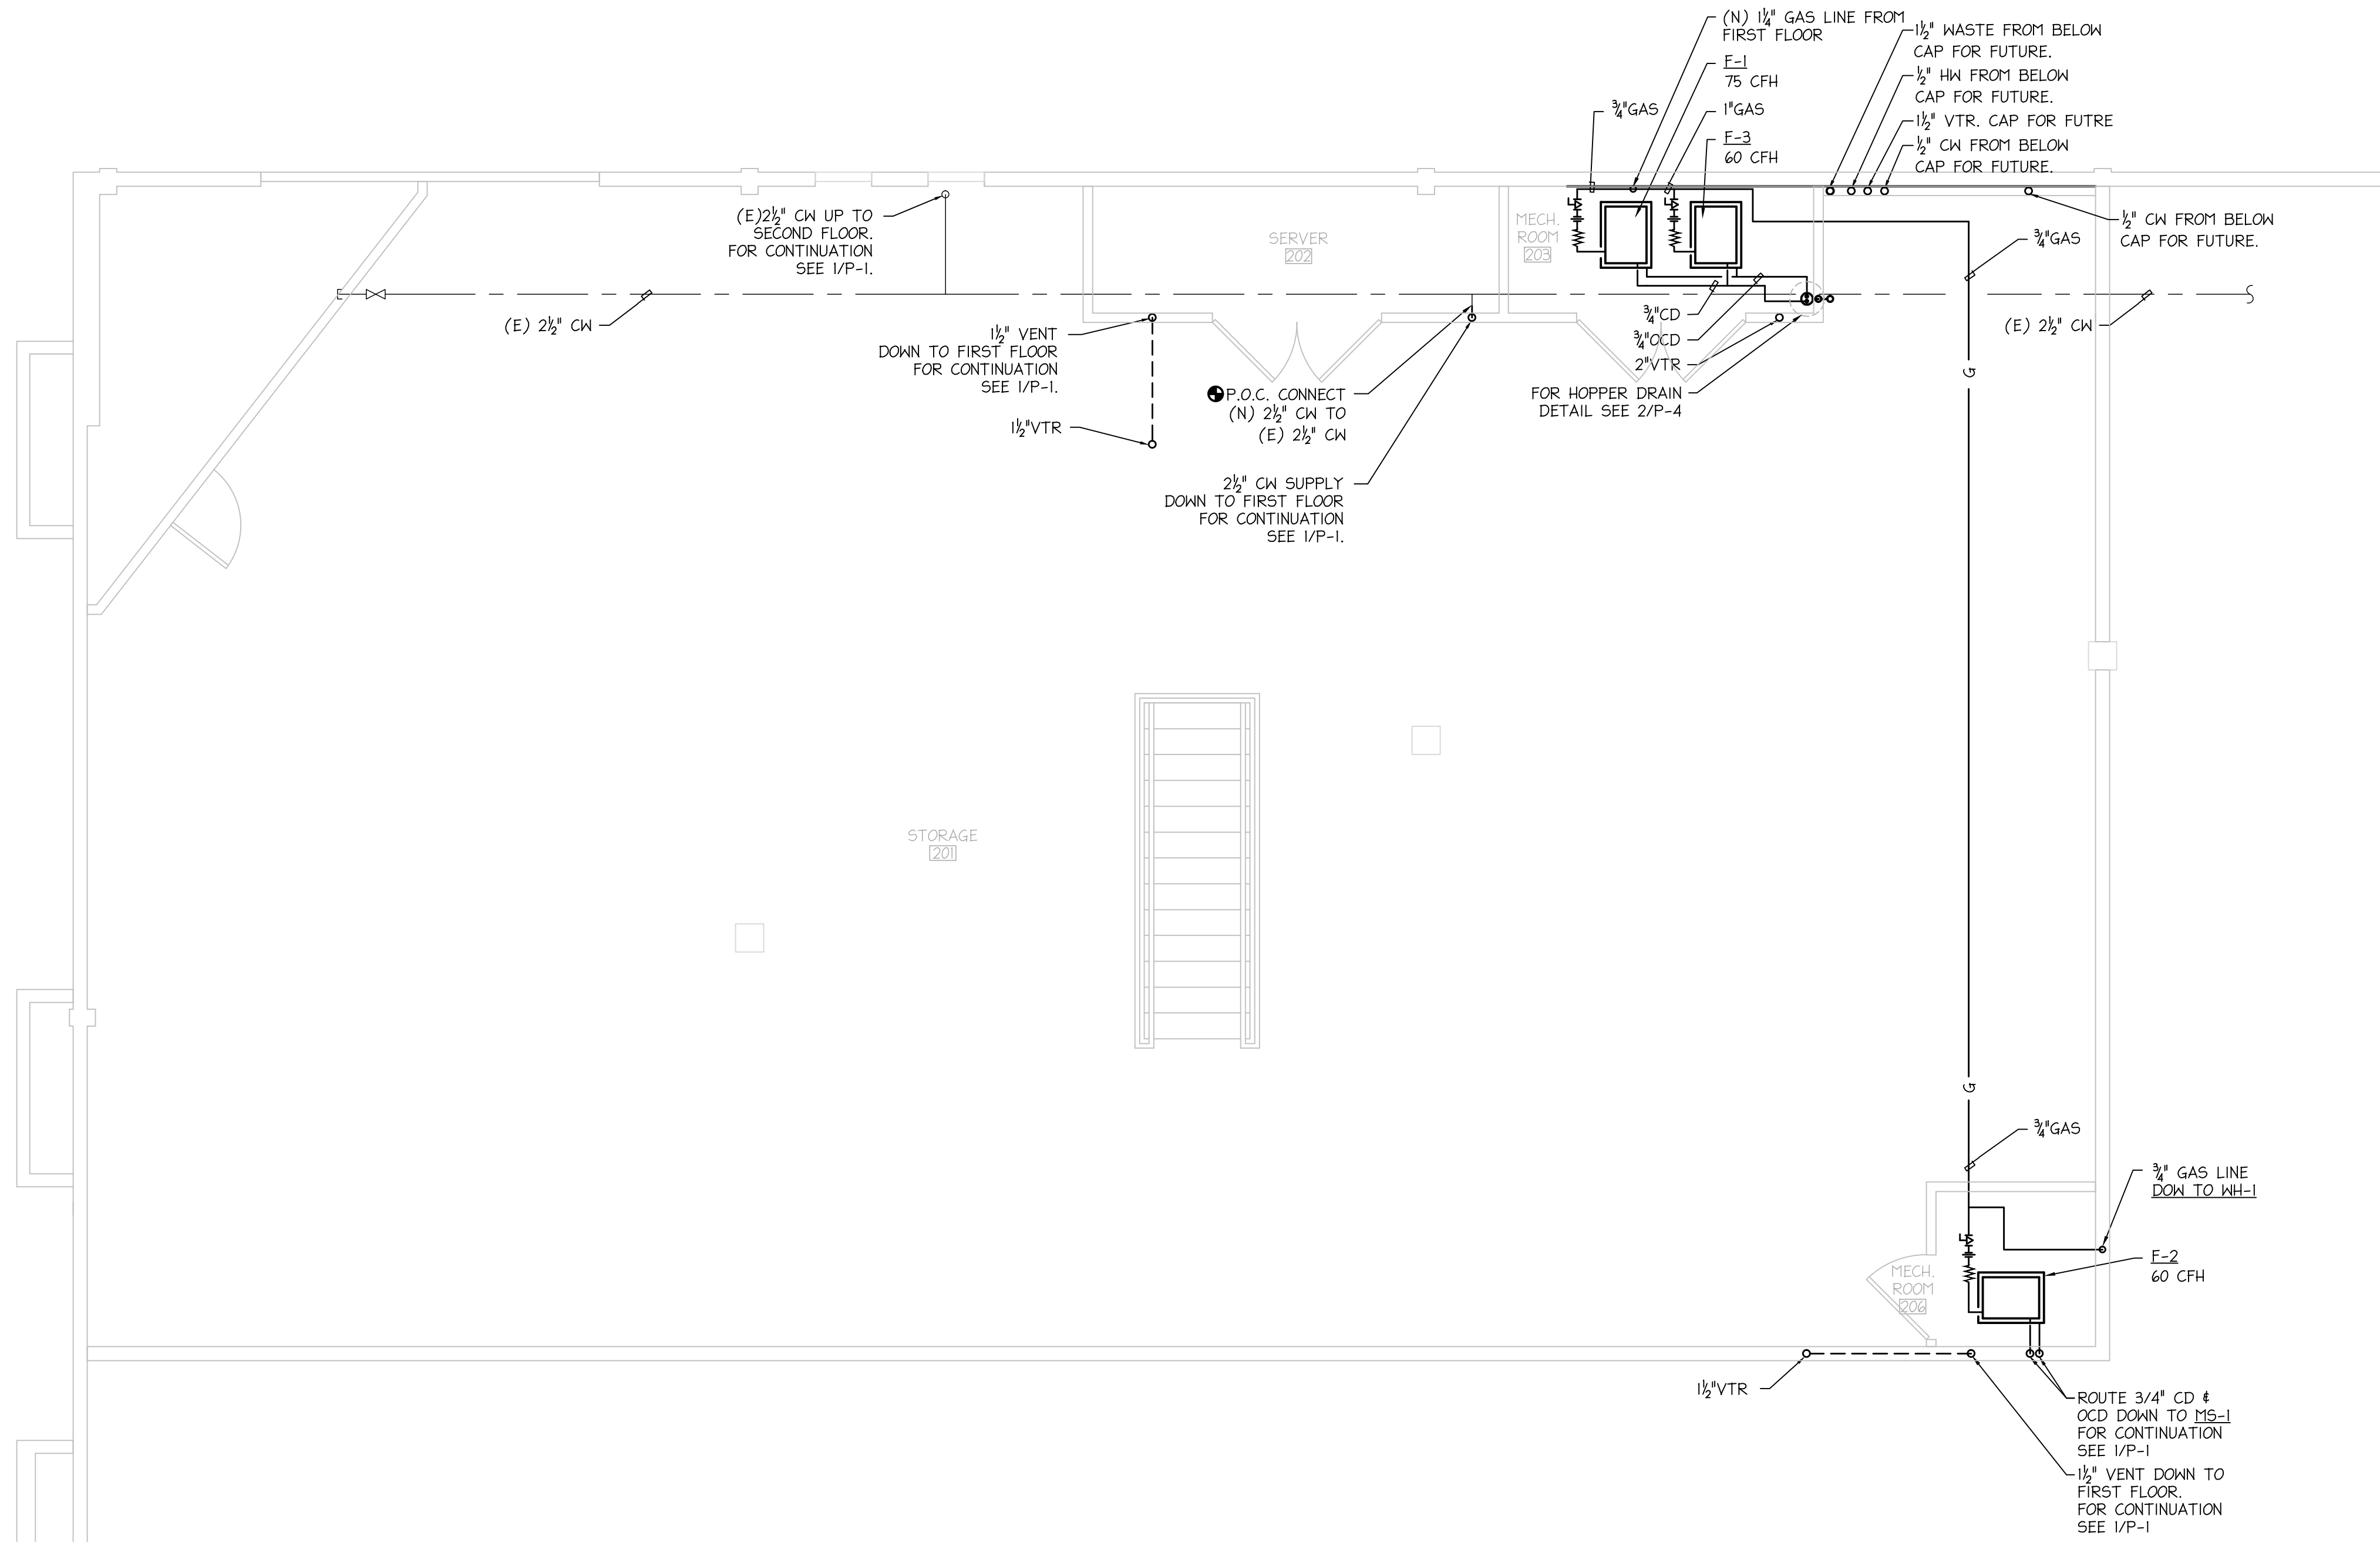

1
P-2

SECOND FLOOR PLUMBING PLAN

SCALE: 1/4" = 1'-0"



Consulting Mechanical Engineers
1400 Lone Palm Ave.
Suite A
Modesto, CA 95351
Tel: 209.572.7399 Fax: 209.236.1579
WWW.NEXUSENGINEERING.COM
HVAC, Plumbing/Piping, Fire Sprinklers
Process/Plant Engineering, Refrigeration

TENANT IMPROVEMENT FOR

GRANITE REALTY

CORNERSTONE MALL
2000 BRIGGSMORE
MODESTO, CALIFORNIA

REVISIONS:

DRAWN:	RLH
DATE:	07/19/2010
FILE:	424-ALL
JOB:	44,424
PRINT DATE:	

SECOND FLOOR
PLUMBING
PLAN

P-2

L Street Architects

L i m i t e d

1404 L Street
Modesto, California 95354
209-575-1415 209-575-4374 fax
www.lstreetarchitects.com